


PRIMARY ELECTRICAL CONTROL SWITCH BOARD

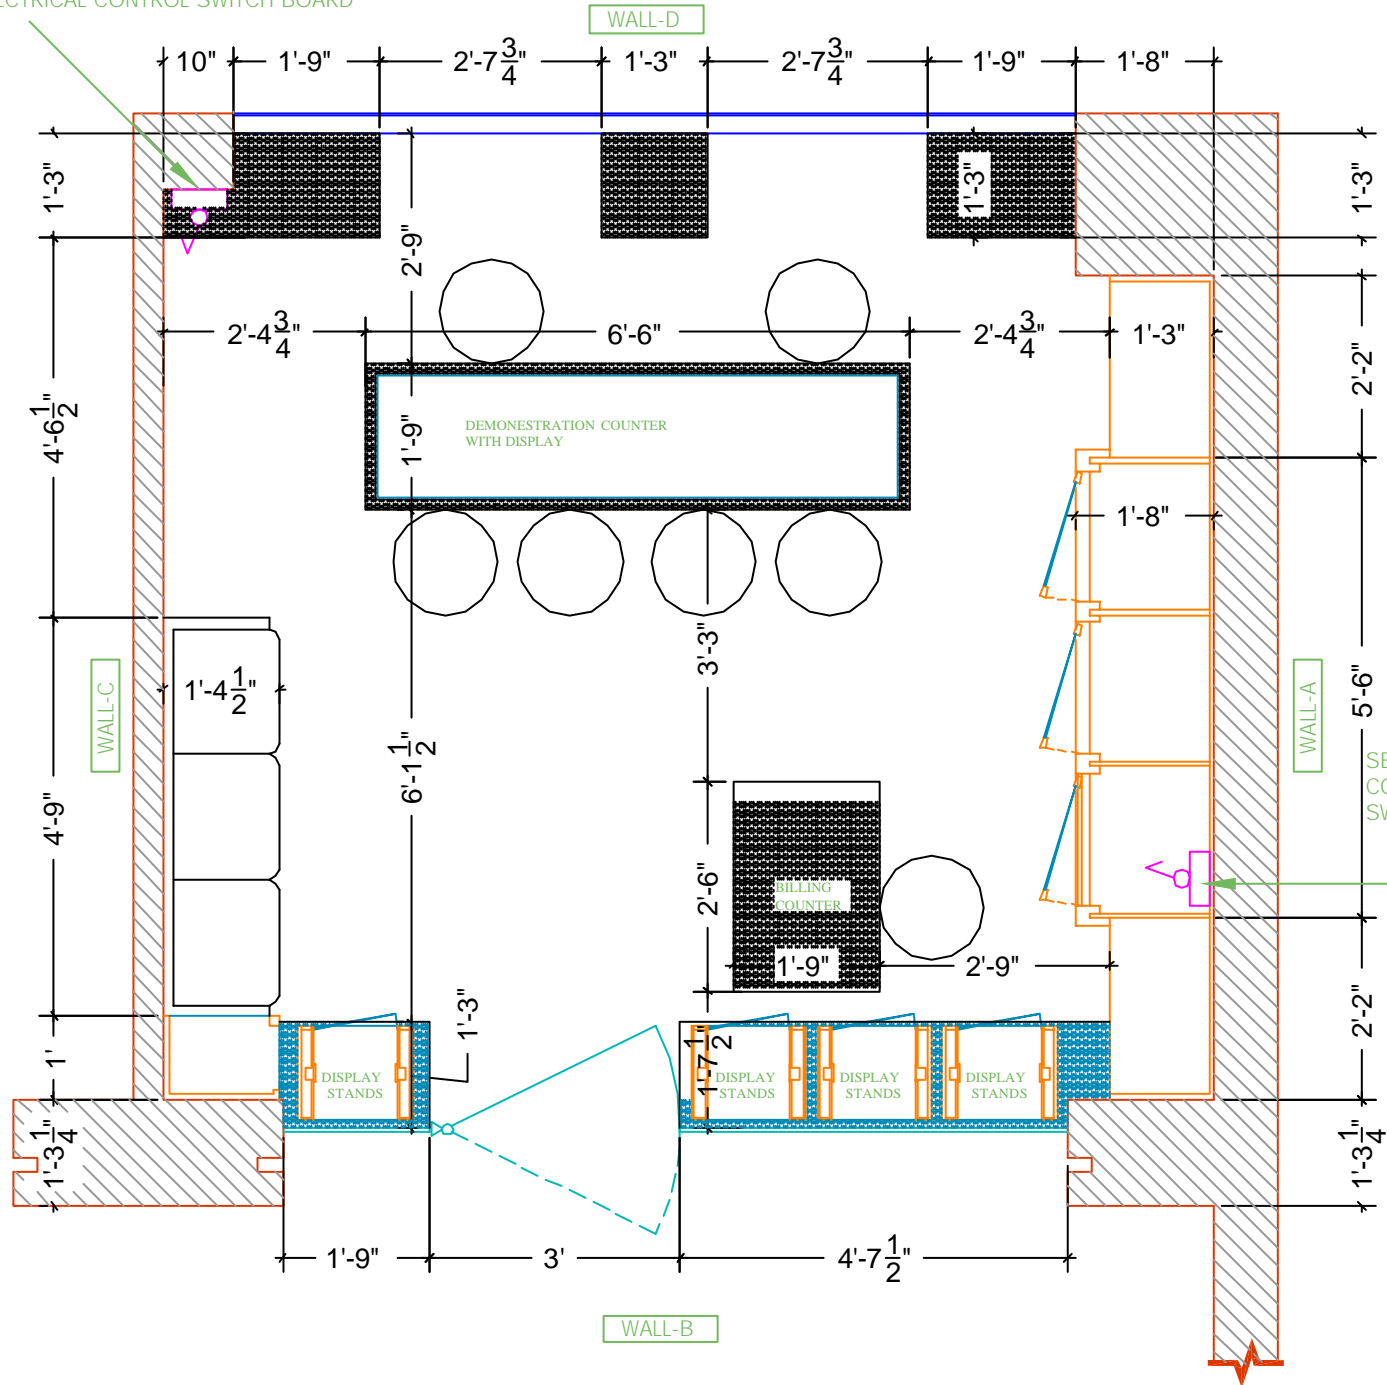

SWITCH BOARD	
TELEPHONE SOCKET OUTLET	
6 AMP SOCKET OUTLET	
15 AMP SOCKET OUTLET	
1" ZOOM LIGHT	
7" C.F.L.	
1/4" EGA FLOOR BOX WITH	
3 nos. 15A POWER PTS.	
2 nos. 5A POWER POINTS (UPS)	
1 no. MUSIC INPUT	
1 no. RJ11 TELEPHONE POINT	
1 CAMERA	

2	
---	--

1. ALL DIMENSIONS ARE TO BE READ ONE TO BE MENTIONED  
 2. ALL DIMENSIONS ARE IN FEET & INCHES  
 3. ALL MATERIALS AND FINISHES MUST BE SPECIFIED & APPROVED BY THE CLIENT BEFORE COMMENCEMENT OF WORK

**PREPARED FOR THE ARCHITECTURE OF**  
**JEWELLERY SHOWROOM**  
 CENTRAL PARK, BANGALORE, INDIA


**PREPARED FOR THE ARCHITECTURE OF**  
**FURNITURE LAYOUT**

CLIENT:	
DESIGNED BY:	
DATE:	
SCALE:	1/4" = 1'-0"
PROJECT NO:	

**STREAM STUDIO**  
 Architecture, Interiors, Landscape, Planner  
 G-407, Convent Nagar, Bangalore (K.A.) India - 560025  
 Contact: 98454 27072, 98454 27073, 98454 27074  
 Website: www.streamstudio.in  
 Mail: @streamstudio@gmail.com

THIS DRAWING IS THE PROPERTY OF STREAM STUDIO, AND SHOULD NOT BE REPRODUCED IN PART OR WHOLE WITHOUT PRIOR PERMISSION FROM THE ARCHITECT.

MK EGA FLOOR BOX WITH  
2 nos. 15A POWER PTS,

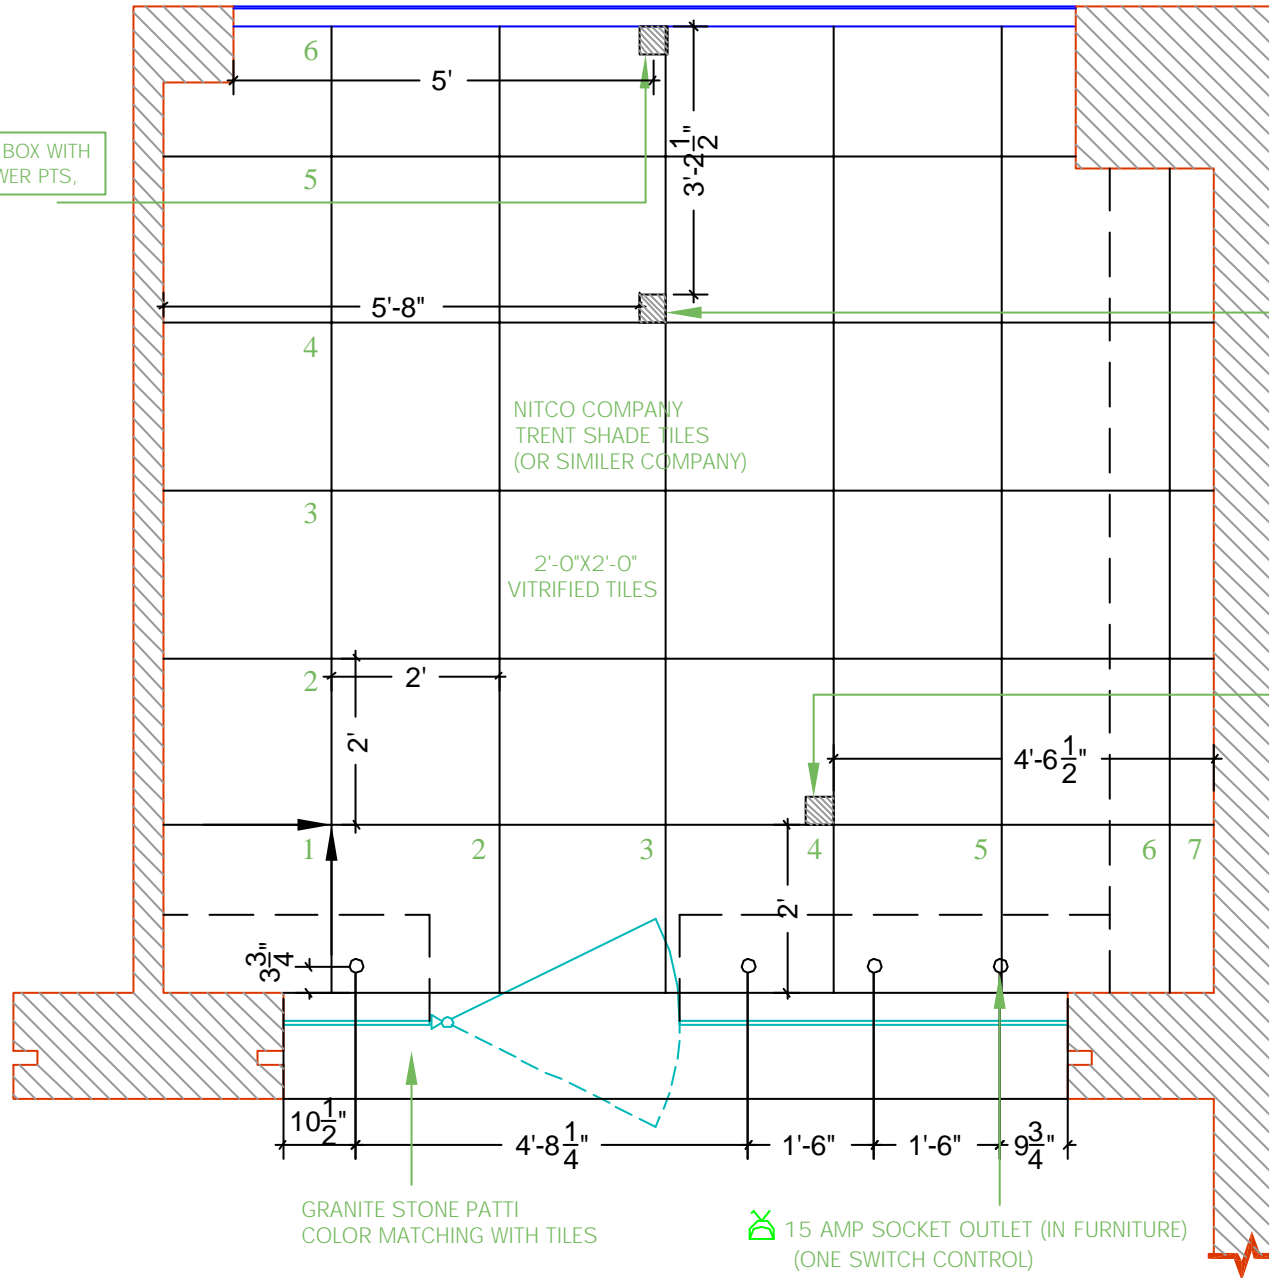

GRANITE STONE PATTI  
COLOR MATCHING WITH TILES

15 AMP SOCKET OUTLET (IN FURNITURE)  
(ONE SWITCH CONTROL)

MK EGA FLOOR BOX WITH  
2 nos. 15A POWER PTS,  
2 nos. 5A POWER POINTS,  
1 no. RJ11 TELEPHONE POINT

MK EGA FLOOR BOX WITH  
2 nos. 15A POWER PTS,  
2 nos. 5A POWER POINTS,  
MUSIC INPUT(SPEAKAR COTR.)  
1 no. RJ11 TELEPHONE POINT  
1 CAMERA OUTPUT

SWITCH BOARD	
TELEPHONE SOCKET OUTLET	
5 AMP SOCKET OUTLET	
15 AMP SOCKET OUTLET	
1" ZOOM LIGHT	
7" C.F.L.	

2	MK EGA FLOOR BOX WITH 2 nos. 15A POWER PTS, 2 nos. 5A POWER POINTS (UPS), 1 no. MUSIC INPUT 1 no. RJ11 TELEPHONE POINT 1 CAMERA
---	------------------------------------------------------------------------------------------------------------------------------------------------

1. ALL DIMENSIONS ARE TO BE READ ONE TO BE MARKED  
2. ALL DIMENSIONS ARE IN FEET & INCHES  
3. ALL DIMENSIONS AND CONSTRUCTION MUST BE CHECKED & CORRECTED WITH STRUCTURAL OFFICES

PROJECTED INTERIOR DESIGN OF  
**JEWELLERY SHOWROOM**  
CONTRACT: SPACING, ELECTRICAL, SANITARY (MECHANICAL)


CLIENT: JEWELLERY SHOWROOM

DESIGNED BY: AR. DIPJ BAMBHA

SCALE: 1/8" = 1'-0"

**STREAM STUDIO**  
Architecture, Interiors, Landscape, Planner  
G-417/1, Connaught Place, Indraprastha, Delhi-110028  
Contact: 91-11-42707521, 110-11-42707521  
Website: www.streamstudio.in  
Mail: @streamstudio@gmail.com

THIS DRAWING IS THE PROPERTY OF STREAM STUDIO, AND SHOULD NOT BE REPRODUCED IN PART OR WHOLE WITHOUT PRIOR PERMISSION FROM THE ARCHITECT.

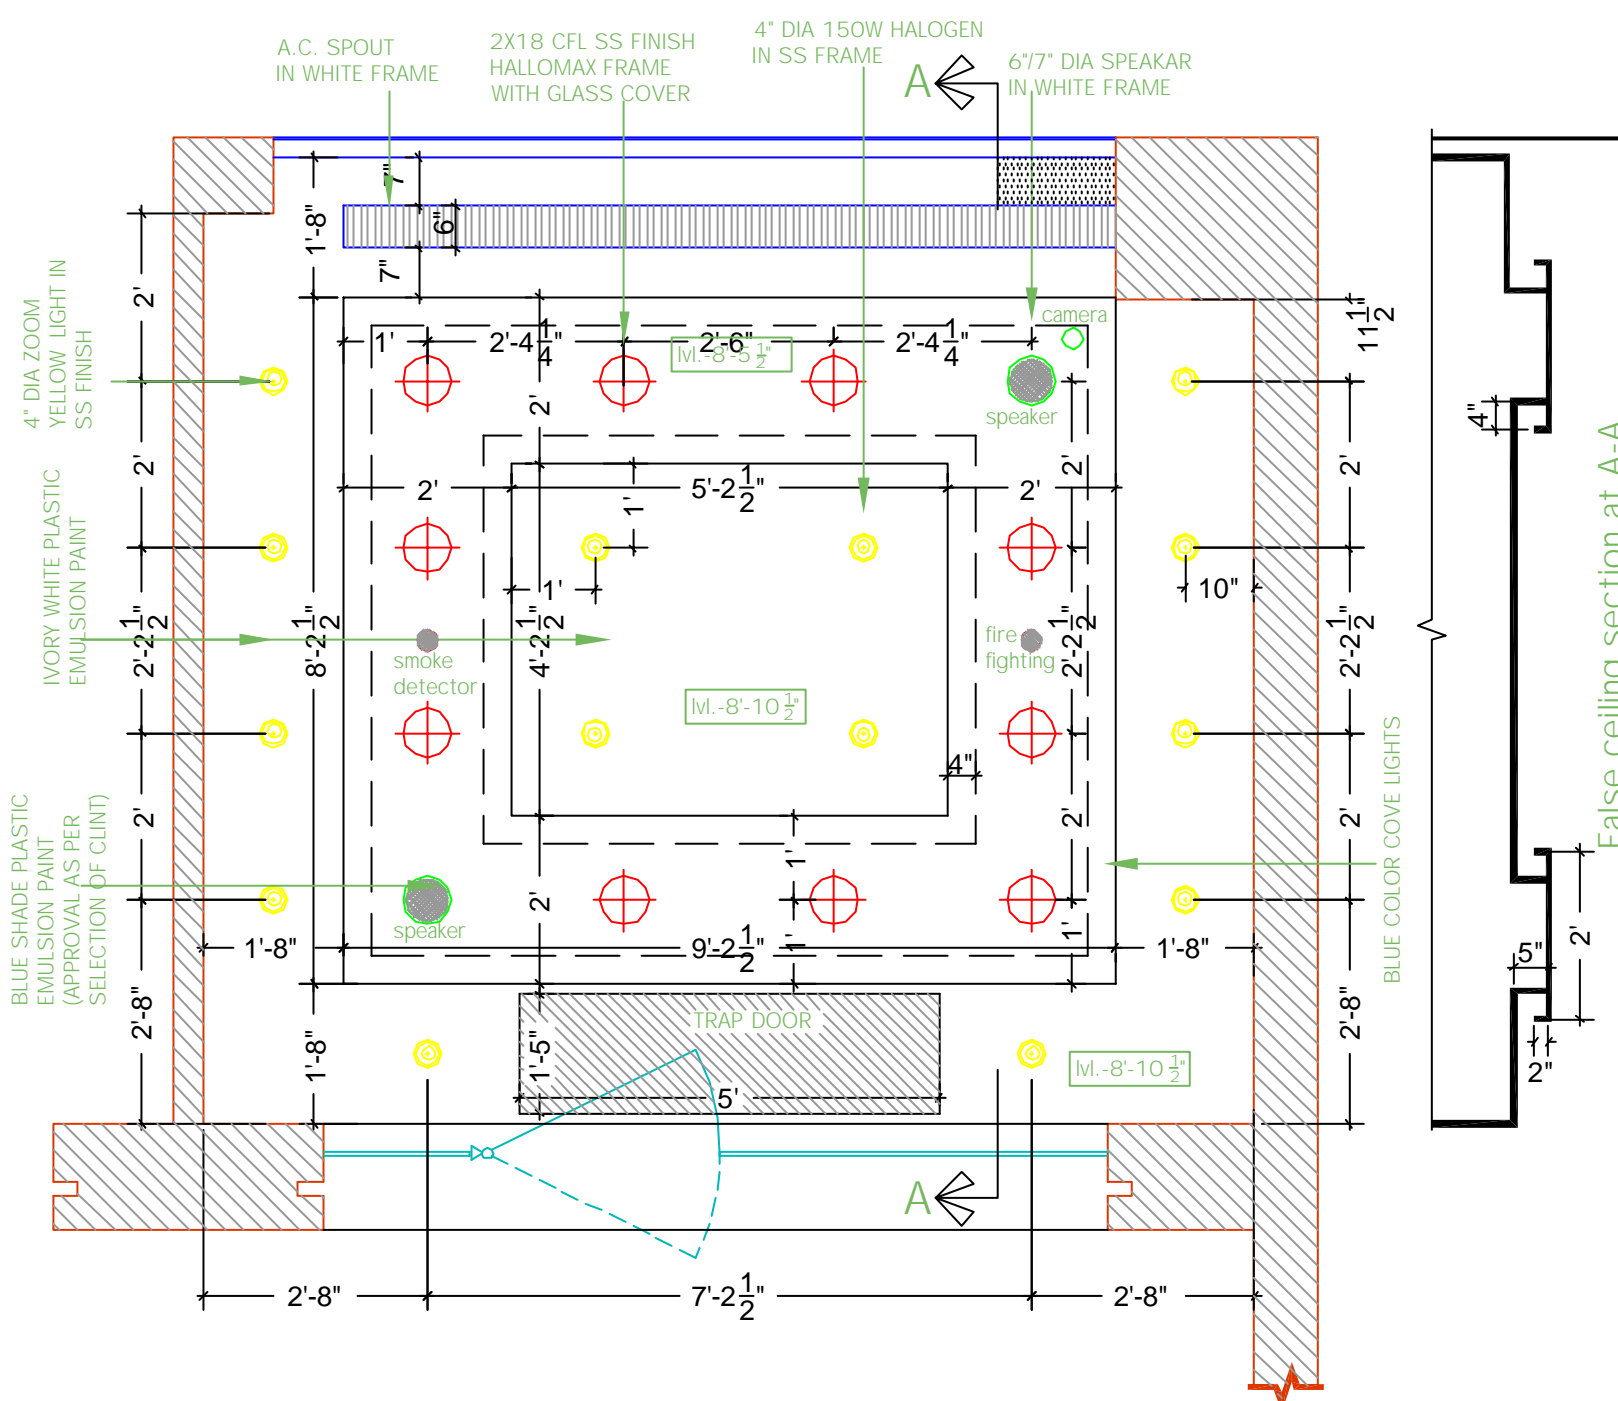

SWITCH BOARD	
TELEPHONE SOCKET OUTLET	
6 AMP SOCKET OUTLET	
15 AMP SOCKET OUTLET	
1" ZOOM LIGHT	
7" C.F.L.	

- 1. 1/2" EGA FLOOR BOX WITH
- 2 nos. 15A POWER PTS.
- 2 nos. 5A POWER POINTS (UPS).
- 1 no. MUSIC INPUT
- 1 no. RJ11 TELEPHONE POINT
- 1 CAMERA

False ceiling section at A-A

1. ALL DIMENSIONS ARE TO BE READ ONE TO BE MARKED  
 2. ALL DIMENSIONS ARE IN FEET & INCH.  
 3. ALL MATERIALS AND COMPONENTS MUST BE SPECIFIED & APPROVED WITH SUPPLIER'S APPROVAL.

PROJECT: PROPOSED JEWELLERY SHOWROOM OF JEWELLARY SHOWROOM

CLIENT: JALALUDDIN CEILING WITH ELECTRICAL.

DESIGNER: [Signature]


DATE: [Date]

SCALE: 1/8" = 1'-0"

PROJECT NO: [Number]

**STREAM STUDIO**  
 Architecture, Interiors, Landscape, Planner  
 G-417, Convent Nagar, Behind (P.S.) Datta, Opposite  
 Datta 15, - 75 102-070752, 1st - 1st, (P.S.) Datta - 4074  
 Website: www.streamstudio.in  
 Mail: @streamstudio@gmail.com

THIS DRAWING IS THE PROPERTY OF STREAM STUDIO, AND SHOULD NOT BE REPRODUCED IN PART OR WHOLE WITHOUT PRIOR PERMISSION FROM THE ARCHITECT.

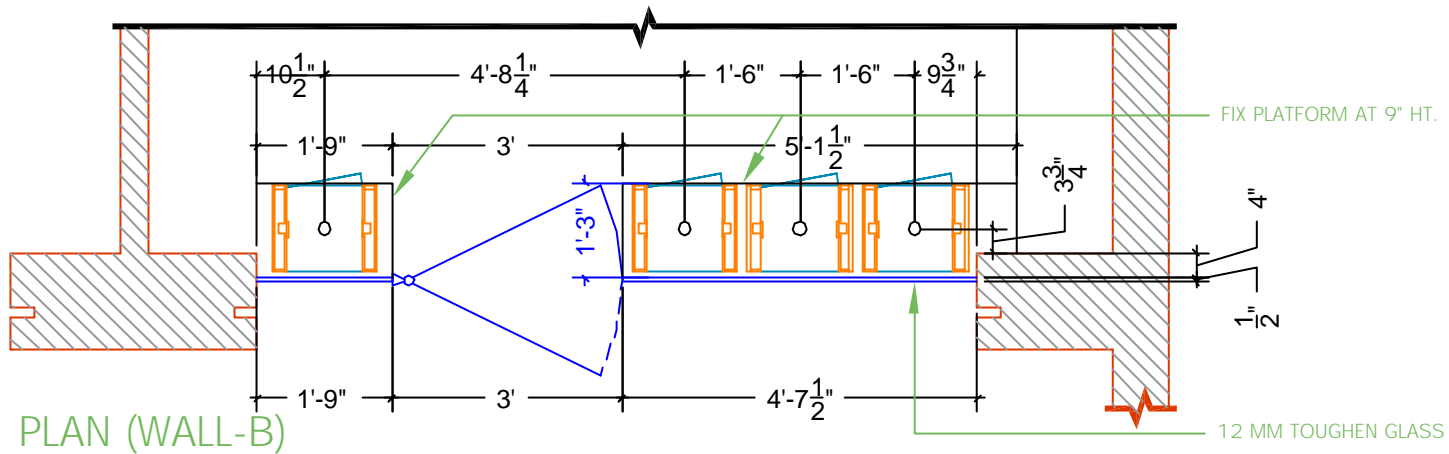


PLAN (WALL-B)

SWITCH BOARD	
TELEPHONE SOCKET OUTLET	
6 AMP SOCKET OUTLET	
15 AMP SOCKET OUTLET	
1" ZOOM LIGHT	
7" C.F.L.	

- 2
- 1x IGA FLOOR BOX WITH
  - 3 nos. 15A POWER PTS.
  - 2 nos. 5A POWER POINTS (UPS).
  - 1 no. MUSIC INPUT
  - 1 no. RJ11 TELEPHONE POINT
  - 1 CAMERA

NOTE: ALL GLASS FITTING SHOULD BE IN SS FINISH

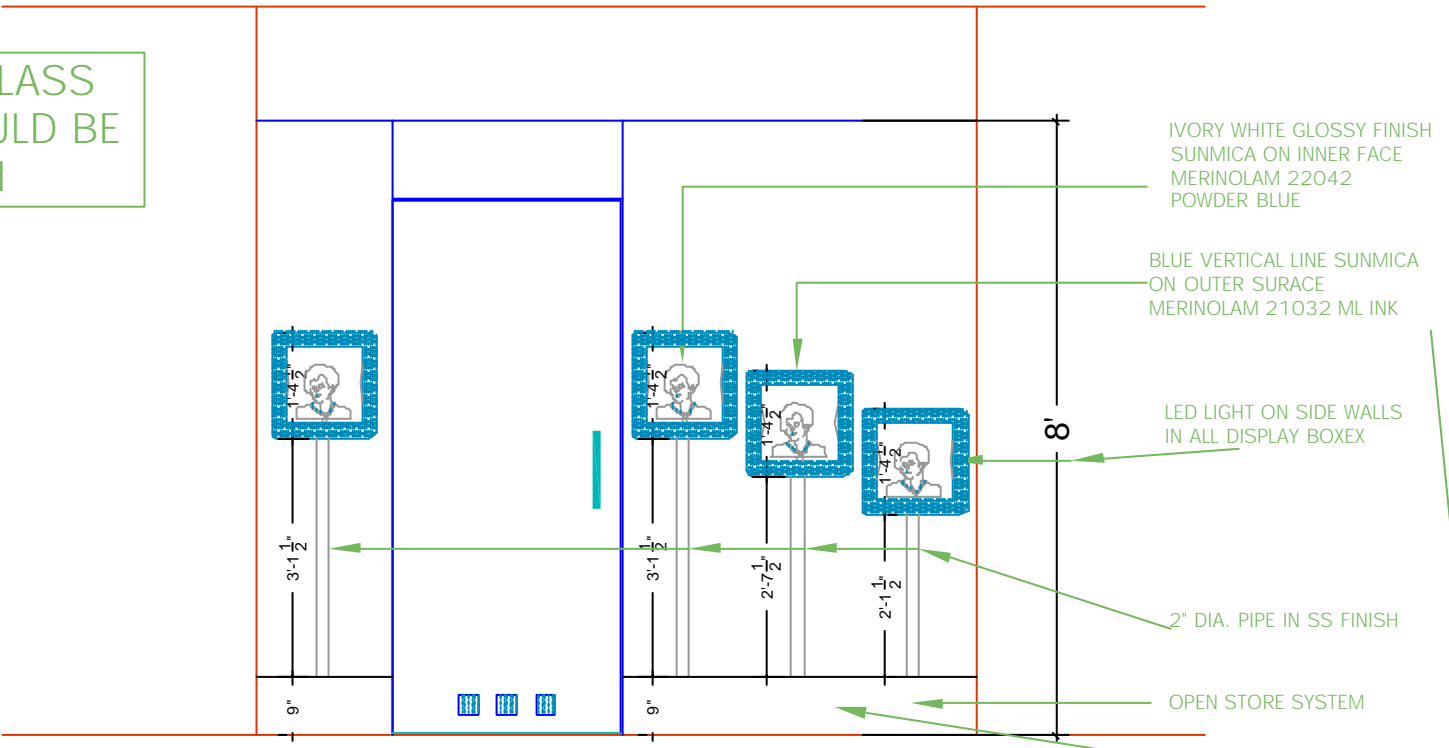

ELEVATION (WALL-B)

1. ALL DIMENSIONS ARE TO BE READ ONE TO BE MENTIONED
2. ALL DIMENSIONS ARE IN FEET & INCH.
3. ALL DIMENSIONS AND CONSTRUCTION MUST BE CHECKED & CORRECTED WITH STRUCTURAL OFFICES.


PREPARED FOR THE ARCHITECTURE OF  
**JEWELLERY SHOWROOM**  
 CENTRAL SPACE, 2ND FLOOR, BANGKOK (THAILAND)

DATE: 15/05/2014  
**WALL ELEVATION**


CLIENT:	
DESIGN BY:	MR. A. D. P. BANNA
CHECKED BY:	
SCALE:	1/4" = 1'-0"
PROJECT NO.:	

**STREAM STUDIO**  
 Architecture, Interiors, Landscape, Planner  
 G-417, Central Market, Rajabhat (Rajabhat) Building  
 Chulalongkorn Road, Bangkok 10100, THAILAND  
 Website: www.streamstudio.com  
 Mail: @streamstudio@gmail.com

THIS DRAWING IS THE PROPERTY OF STREAM STUDIO, AND SHOULD NOT BE REPRODUCED IN PART OR WHOLE WITHOUT PRIOR PERMISSION FROM THE ARCHITECT.

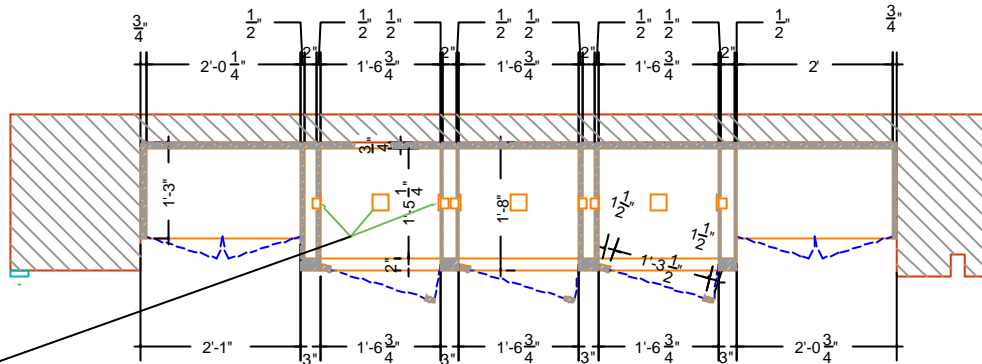

PLAN (WALL-A)

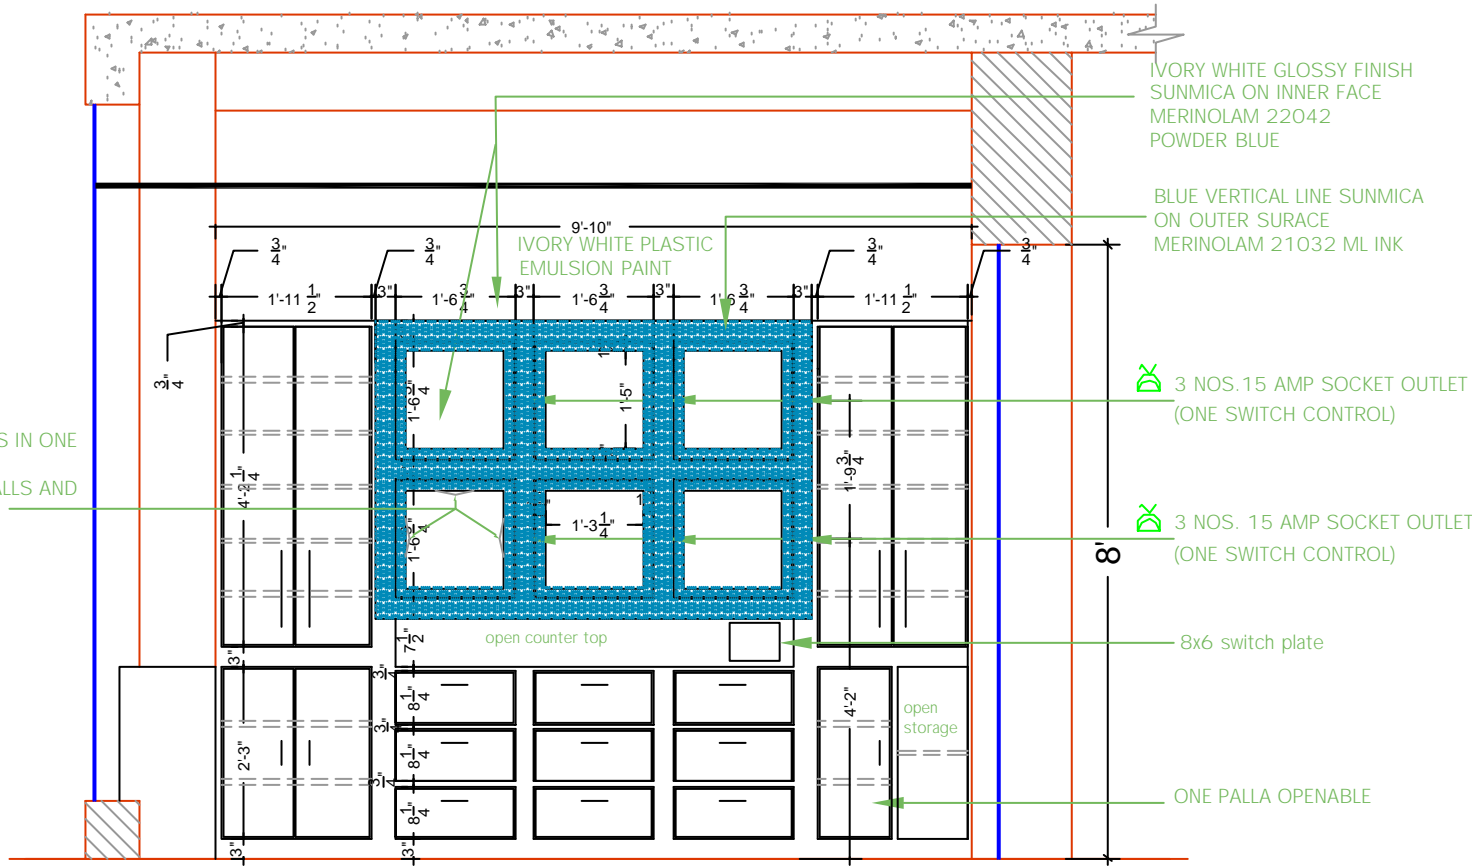

ELEVATION (WALL-A)

THREE LED LIGHTS IN ONE UNIT  
TWO ON SIDE WALLS AND ONE ON TOP

IVORY WHITE GLOSSY FINISH SUNMICA ON INNER FACE  
MERINOLAM 22042 POWDER BLUE

BLUE VERTICAL LINE SUNMICA ON OUTER SURFACE  
MERINOLAM 21032 ML INK

IVORY WHITE PLASTIC EMULSION PAINT

3 NOS. 15 AMP SOCKET OUTLET  
(ONE SWITCH CONTROL)

3 NOS. 15 AMP SOCKET OUTLET  
(ONE SWITCH CONTROL)

8x6 switch plate

ONE PALLA OPENABLE

SWB	1	SWITCH BOARD
TS	3	TELEPHONE SOCKET OUTLET
OS	3	15 AMP SOCKET OUTLET
ZL	1	7" ZOOM LIGHT
CF	1	7" C.F.L.

2	1/1K EGA FLOOR BOX WITH
	3 nos. 15A POWER PTS.
	2 nos. 5A POWER POINTS (UPS).
	1 no. MUSIC INPUT
	1 no. RJ11 TELEPHONE POINT
	1 CAMERA

1. ALL DIMENSIONS ARE TO BE READ ONE TO BE MINOR  
2. ALL DIMENSIONS ARE IN FEET & INCH.  
3. ALL MATERIALS AND COMPONENTS MUST BE CHECKED & CONFIRMED WITH SUPPLIER OFFICES.

FOR ALL DIMENSIONS REFER TO BE READ ONE TO BE MINOR  
FOR ALL DIMENSIONS ARE IN FEET & INCH.  
FOR ALL MATERIALS AND COMPONENTS MUST BE CHECKED & CONFIRMED WITH SUPPLIER OFFICES.


PROFESSIONAL ARCHITECTURE SERVICES OF  
**JEWELLERY SHOWROOM**  
CONTRACT NO. 2024/01/01, BANGALORE (KARNATAKA)

DRAWN BY: <b>WALL ELEVATION</b>	
CLIENT:	
DESIGN BY: <b>DR. DIP BAMBAL</b>	CHECKED BY:
DATE:	SCALE: 1/4" = 1'-0"
DWG NO: 04	PROJECT NO:

**STREAM STUDIO**  
Architecture, Interiors, Landscape, Planner  
G-407, Convent Nagar, 8th Cross, 8th Stage, Old World  
Bangalore - 560075, Karnataka, India. PH: 088611-46781  
Website: www.streamstudio.in  
Mail: @streamstudio@gmail.com

THIS DRAWING IS THE PROPERTY OF STREAM STUDIO, AND SHOULD NOT BE REPRODUCED IN PART OR WHOLE WITHOUT PRIOR PERMISSION FROM THE ARCHITECT.

DEMO COUNTER DETAIL

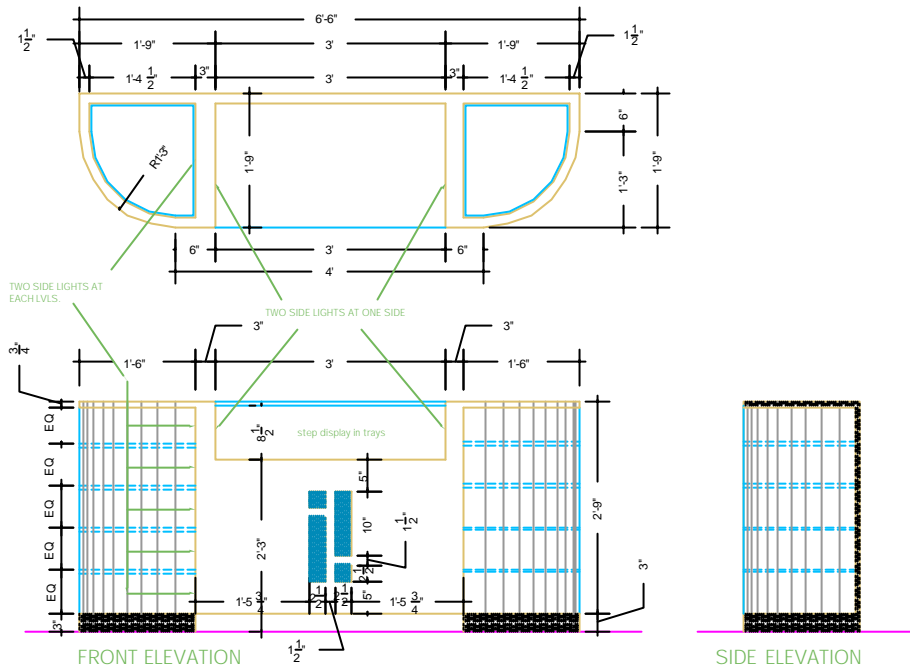


FRONT ELEVATION

SIDE ELEVATION

REAR ELEVATION


WALL DISPLAY DETAIL

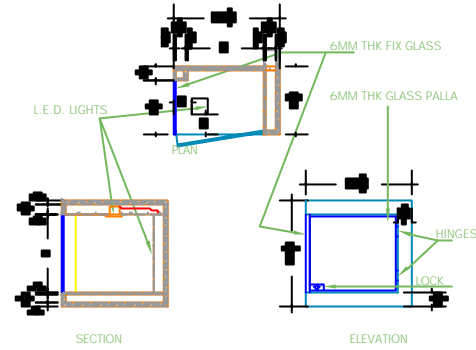

SECTION

ELEVATION


DISPLAY STAND DETAIL

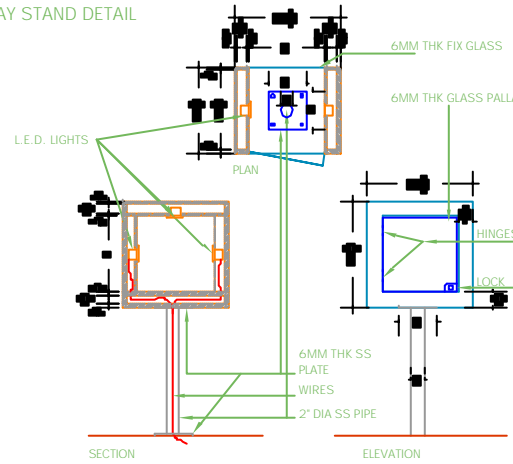

SECTION

ELEVATION

SOFA DETAIL

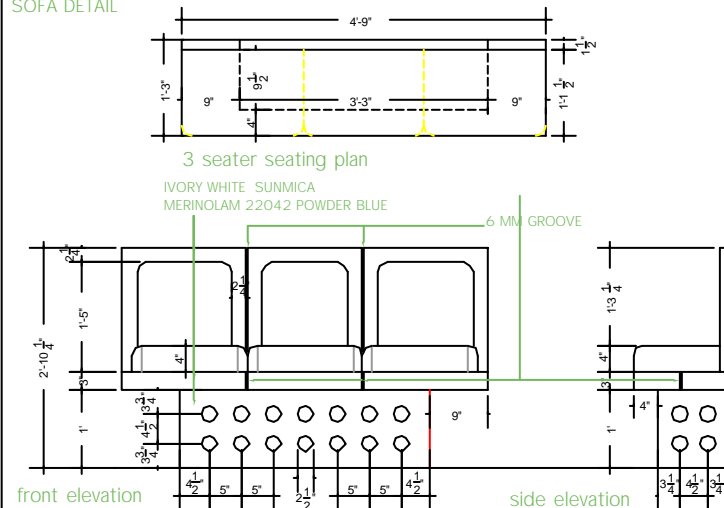

front elevation

side elevation

SWITCH BOARD	
TELEPHONE SOCKET OUTLET	
6 AMP SOCKET OUTLET	
15 AMP SOCKET OUTLET	
1" ZOOM LIGHT	
7" C.F.L.	

2	1/8" EGA FLOOR BOX WITH 3 nos. 15A POWER PTS. 2 nos. 5A POWER POINTS (UPS) 1 no. MUSIC INPUT 1 no. RJ11 TELEPHONE POINT 1 CAMERA
---	-------------------------------------------------------------------------------------------------------------------------------------------------

1. ALL DIMENSIONS ARE TO BE READ ONE TO BE MARKED  
2. ALL DIMENSIONS ARE IN FEET & INCH.  
3. ALL MATERIAL AND COMPONENTS MUST BE ORDERED & CHECKED WITH SUPPLIER OFFICES.

PREPARED FOR THE ARCHITECTURE OFFICE OF  
**JEWELLARY SHOWROOM**  
CONVENT ROAD, CHENNAI, TAMIL NADU (INDIA)


CLIENT: **FURNITURE DETAILS**

DESIGN BY: <b>DR. A.P. SURESH</b>	CHECKED BY:
DRAWN BY: <b>DR. A.P. SURESH</b>	DATE:
SCALE: <b>1/4" = 1'-0"</b>	PROJECT NO:


**STREAM STUDIO**  
Architecture, Interiors, Landscape, Planner  
G-407, Convent Road, Chennai (India) - 600 009  
Contact: 98-40-070752, 98-40-070753  
Website: www.streamstudio.in  
Mail: @streamstudio@gmail.com

THIS DRAWING IS THE PROPERTY OF STREAM STUDIO, AND SHOULD NOT BE REPRODUCED IN PART OR WHOLE WITHOUT PRIOR PERMISSION FROM THE ARCHITECT.

ELECTRICAL CONTROL SWITCH BOARD

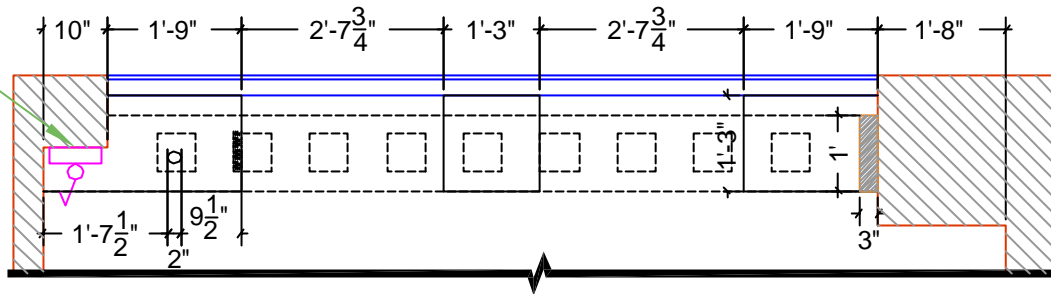

PLAN (WALL-D)

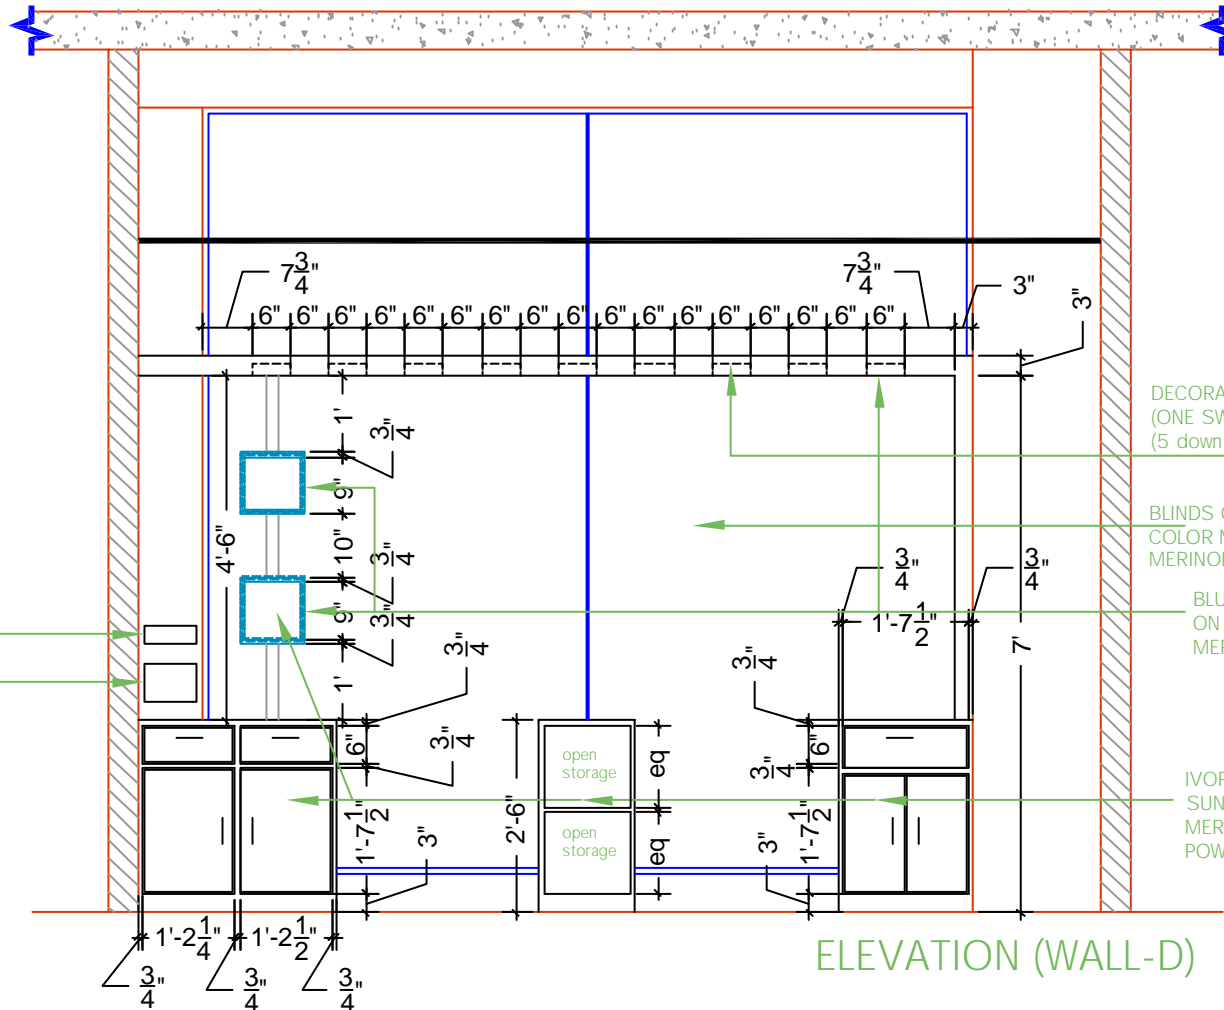

ELEVATION (WALL-D)

DECORATIVE FOCUS LIGHTS  
(ONE SWITCH CONTRL)  
(5 down light & 4 are uplight)

BLINDS ON GLASS TO PROTECT GLARE  
COLOR MATCHING WITH  
MERINOLAM 22042 POWDER BLUE

BLUE VERTICAL LINE SUNMICA  
ON OUTER SURFACE  
MERINOLAM 21032 ML INK

IVORY WHITE GLOSSY FINISH  
SUNMICA ON INNER FACE  
MERINOLAM 22042  
POWDER BLUE

8x3 switch plate  
8x6 switch plate

	SWITCH BOARD	
	TELEPHONE SOCKET OUTLET	
	6 AMP SOCKET OUTLET	
	15 AMP SOCKET OUTLET	
	1" ZOOM LIGHT	
	7" C.F.L.	
<b>2</b>	1/8" EGA FLOOR BOX WITH 3 nos. 15A POWER PTS. 2 nos. 5A POWER POINTS (UPS). 1 no. MUSIC INPUT 1 no. RJ11 TELEPHONE POINT 1 CAMERA	

1. ALL DIMENSIONS ARE TO BE READ ONE TO BE MARKED  
2. ALL DIMENSIONS ARE IN FEET & INCHES  
3. ALL MATERIALS AND FINISHES MUST BE CHECKED & CONFIRMED WITH SUPPLIER OFFICES.

PROJECT NO: 2019010101  
PROPOSED INTERIOR DESIGN OF  
**JEWELLERY SHOWROOM**  
CORNER OF SPADINA AND BAYVIEW, MISSISSAUGA (ON/ONTARIO)

DRAWING TITLE  
**WALL ELEVATION**

CLIENT:

DESIGNED BY: MR. ADIP BANUA

CHECKED BY:


DATE:

SCALE: 1/8" = 1'-0"

PROJECT NO:

**STREAM STUDIO**  
Architecture, Interiors, Landscape, Planner  
60-617, Conwell Village, Aurora (Ont.) M1B 3W9  
Canada 1-800-561-4578 / 416-709-4578  
Website: www.streamstudio.ca  
Email: info@streamstudio.ca

THIS DRAWING IS THE PROPERTY OF STREAM STUDIO, AND SHOULD NOT BE REPRODUCED IN PART OR WHOLE WITHOUT PRIOR PERMISSION FROM THE ARCHITECT.

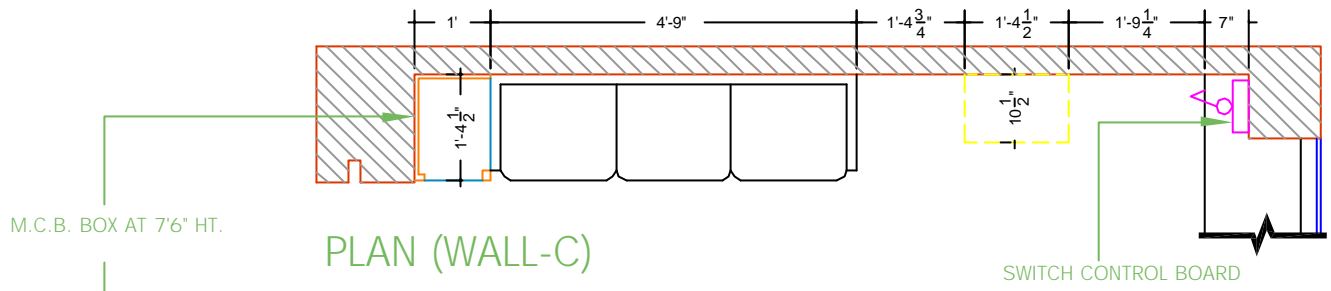


PLAN (WALL-C)

SWITCH CONTROL BOARD

BLUE VERTICAL LINE SUNMICA ON OUTER SURFACE MERINOLAM 21032 ML INK

5 AMP SOCKET OUTLET FOR LIGHT

12 MM GLASS SHELVES

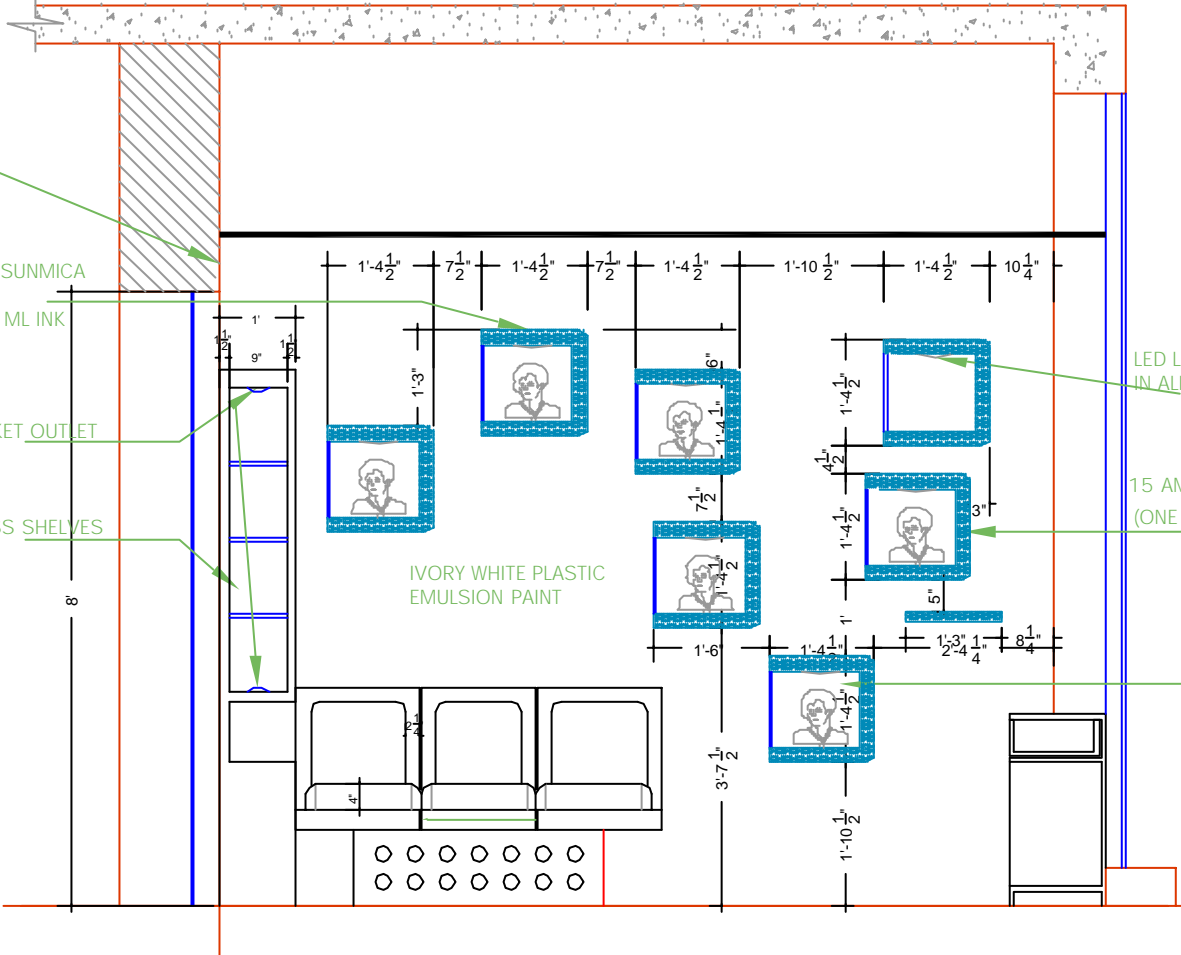

ELEVATION (WALL-C)

SWITCH BOARD	
TELEPHONE SOCKET OUTLET	
5 AMP SOCKET OUTLET	
15 AMP SOCKET OUTLET	
1' ZOOM LIGHT	
7' C.F.L.	
2	1x EGA FLOOR BOX WITH 3 nos. 15A POWER PTS. 2 nos. 5A POWER POINTS (UPS) 1 no. MUSIC INPUT 1 no. RJ11 TELEPHONE POINT 1 CAMERA

1. ALL DIMENSIONS ARE TO BE READ ONE TO BE MENTIONED  
2. ALL DIMENSIONS ARE IN FEET & INCHES  
3. ALL MATERIALS AND COMPONENTS MUST BE CHECKED & CONFIRMED WITH SUPPLIER SPECIFICATIONS.

PROJECT NAME  
**JEWELLERY SHOWROOM**

CLIENT NAME  
**WALL ELEVATION**

CLIENT ADDRESS

DESIGNED BY  
DRAWN BY  
CHECKED BY

DATE  
SCALE : 1/8" = 1'-0"  
PROJECT NO.

STREAM STUDIO  
Architecture, Interiors, Landscape, Planner  
G-417/7, Convent Nagar, Indira Park, Indira Nagar  
Chennai-600 042. Ph: 9840117313, 9840117314, 9840117315  
Website: www.streamstudio.in  
Mail: @streamstudio@gmail.com

THIS DRAWING IS THE PROPERTY OF STREAM STUDIO , AND SHOULD NOT BE REPRODUCED IN PART OR WHOLE WITHOUT PRIOR PERMISSION FROM THE ARCHITECT.